


Corn Exchange, Newbury

Lighting Plan 1:50@A3

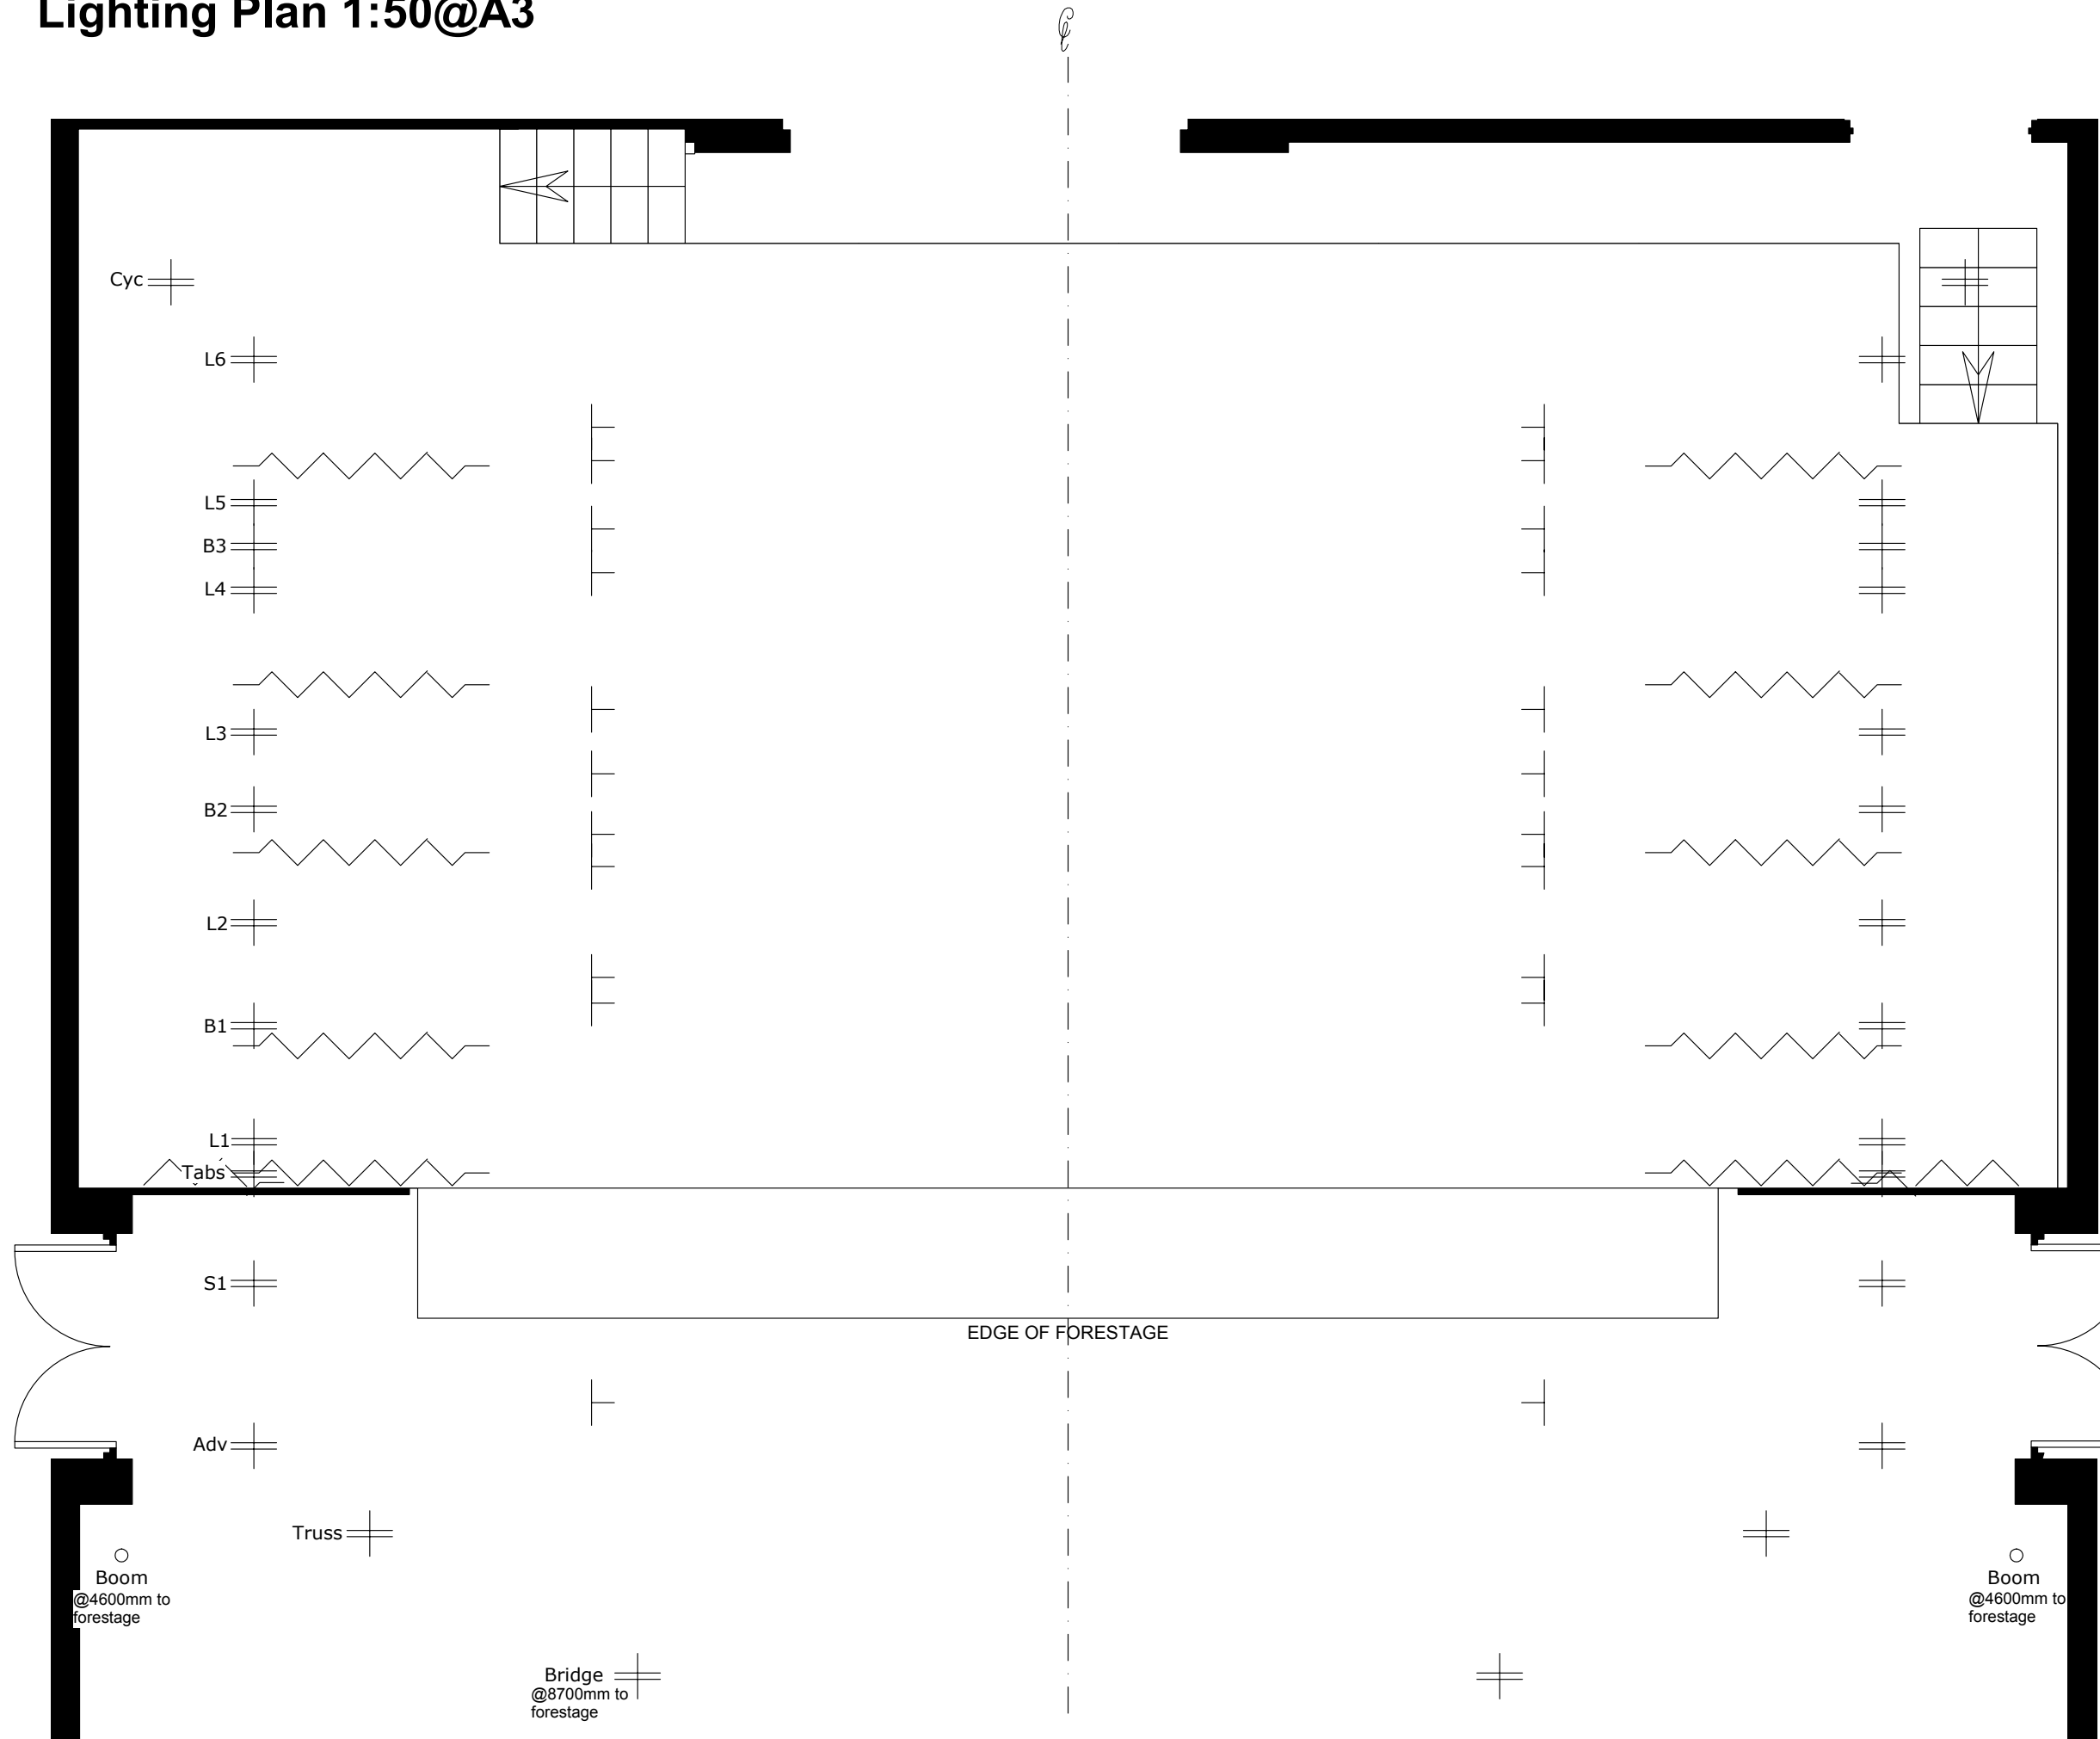

The Corn Exchange
 Market Place
 NEWBURY
 Berkshire
 RG14 5BD
 Tel: 01635 582666
 Fax: 01635 582223



LX Heights from Stage

FOH Bridge @ 9100mm (fixed)
 FOH Booms @ 1600mm - 7500mm (fixed)
 FOH Truss @ 6200mm (max trim)
 FOH Advance bar @ 6200mm (max trim)

LX bars 1-5 @ 6000mm (max trim)
 LX bar 6 @ 5800mm (max trim)

Scale: 1:50@A3

